


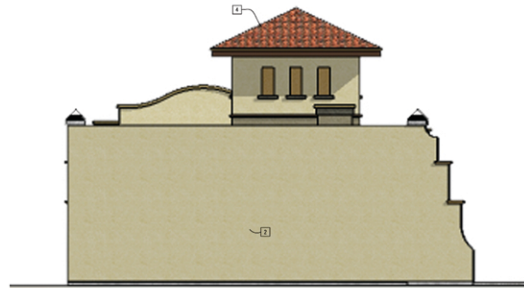

NORTH ELEVATION




EAST ELEVATION



WEST ELEVATION

ELEVATION NOTES

- 1 = NOTE USED IF BOXED
- 2 EXISTING PAINTED BLOCK WALL
- 3 NEW PAINTED BLOCK WALL
- 4 STUCCO OVER FRAMED COLUMN OR ARCH
- 5 ROOFING MATERIAL - EAGLE 5-TILE OR EQUIV.
- 6 STOREFRONT GLAZING
- 7 FRAMED LATTICE
- 8 ABRINGACANOPY PER OWNER
- 9 RAIN-CROSS EMBLEM
- 10 LIGHTING FIXTURE PER LIGHTING PLAN
- 11 BUSINESS SIGN PER TENANT
- 12 BUILDING TRIM - PREFORMED FOAM W/ STUCCO
- 13 STONE VENEER GARDEN WALL

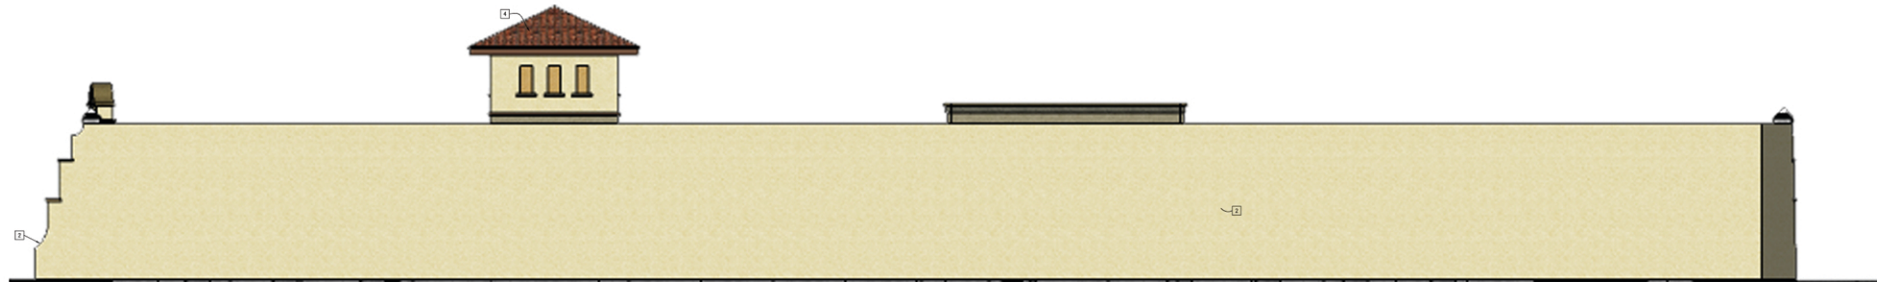

SOUTH ELEVATION

REVISIONS	DATE

NEW BUILDING
MAIN STREET RETAIL CENTER
 1710 MAIN ST.
 RIVERSIDE, CA 92501

GERHART AND ASSOCIATES
 7618 GERTTICH AVE.
 HIGHLAND, CA 92346
 (909) 289-8996



DATE	09-06-07
SCALE	1/8" = 1'-0"
DRAWN BY	RC
JOB	CO 166

SHEET
2.0